



NO.	REVISION	DATE	BY	CHKD.	APP'D.
1	ISSUED FOR PERMIT	2021.03.03	MM	MM	MM
2	ISSUED FOR CONSTRUCTION	2021.03.03	MM	MM	MM
3	ISSUED FOR CONSTRUCTION	2021.03.03	MM	MM	MM
4	ISSUED FOR CONSTRUCTION	2021.03.03	MM	MM	MM

SEAL	CONSULTANT
------	------------


SEAL

CONSULTANT


YQR DISTILLERY
1776 11 AVENUE, REGINA, SK S4T 4P2
BUILDING PERMIT VARIANCE - 2021.10.15

DDC
architecture + urban planning
9916 - 81 Ave Edmonton, Alberta, T6E 1W6
780-428-8001 | tdarch.com

**A210-
DISTILLERY +
WAREHOUSE FLOOR
PLAN**

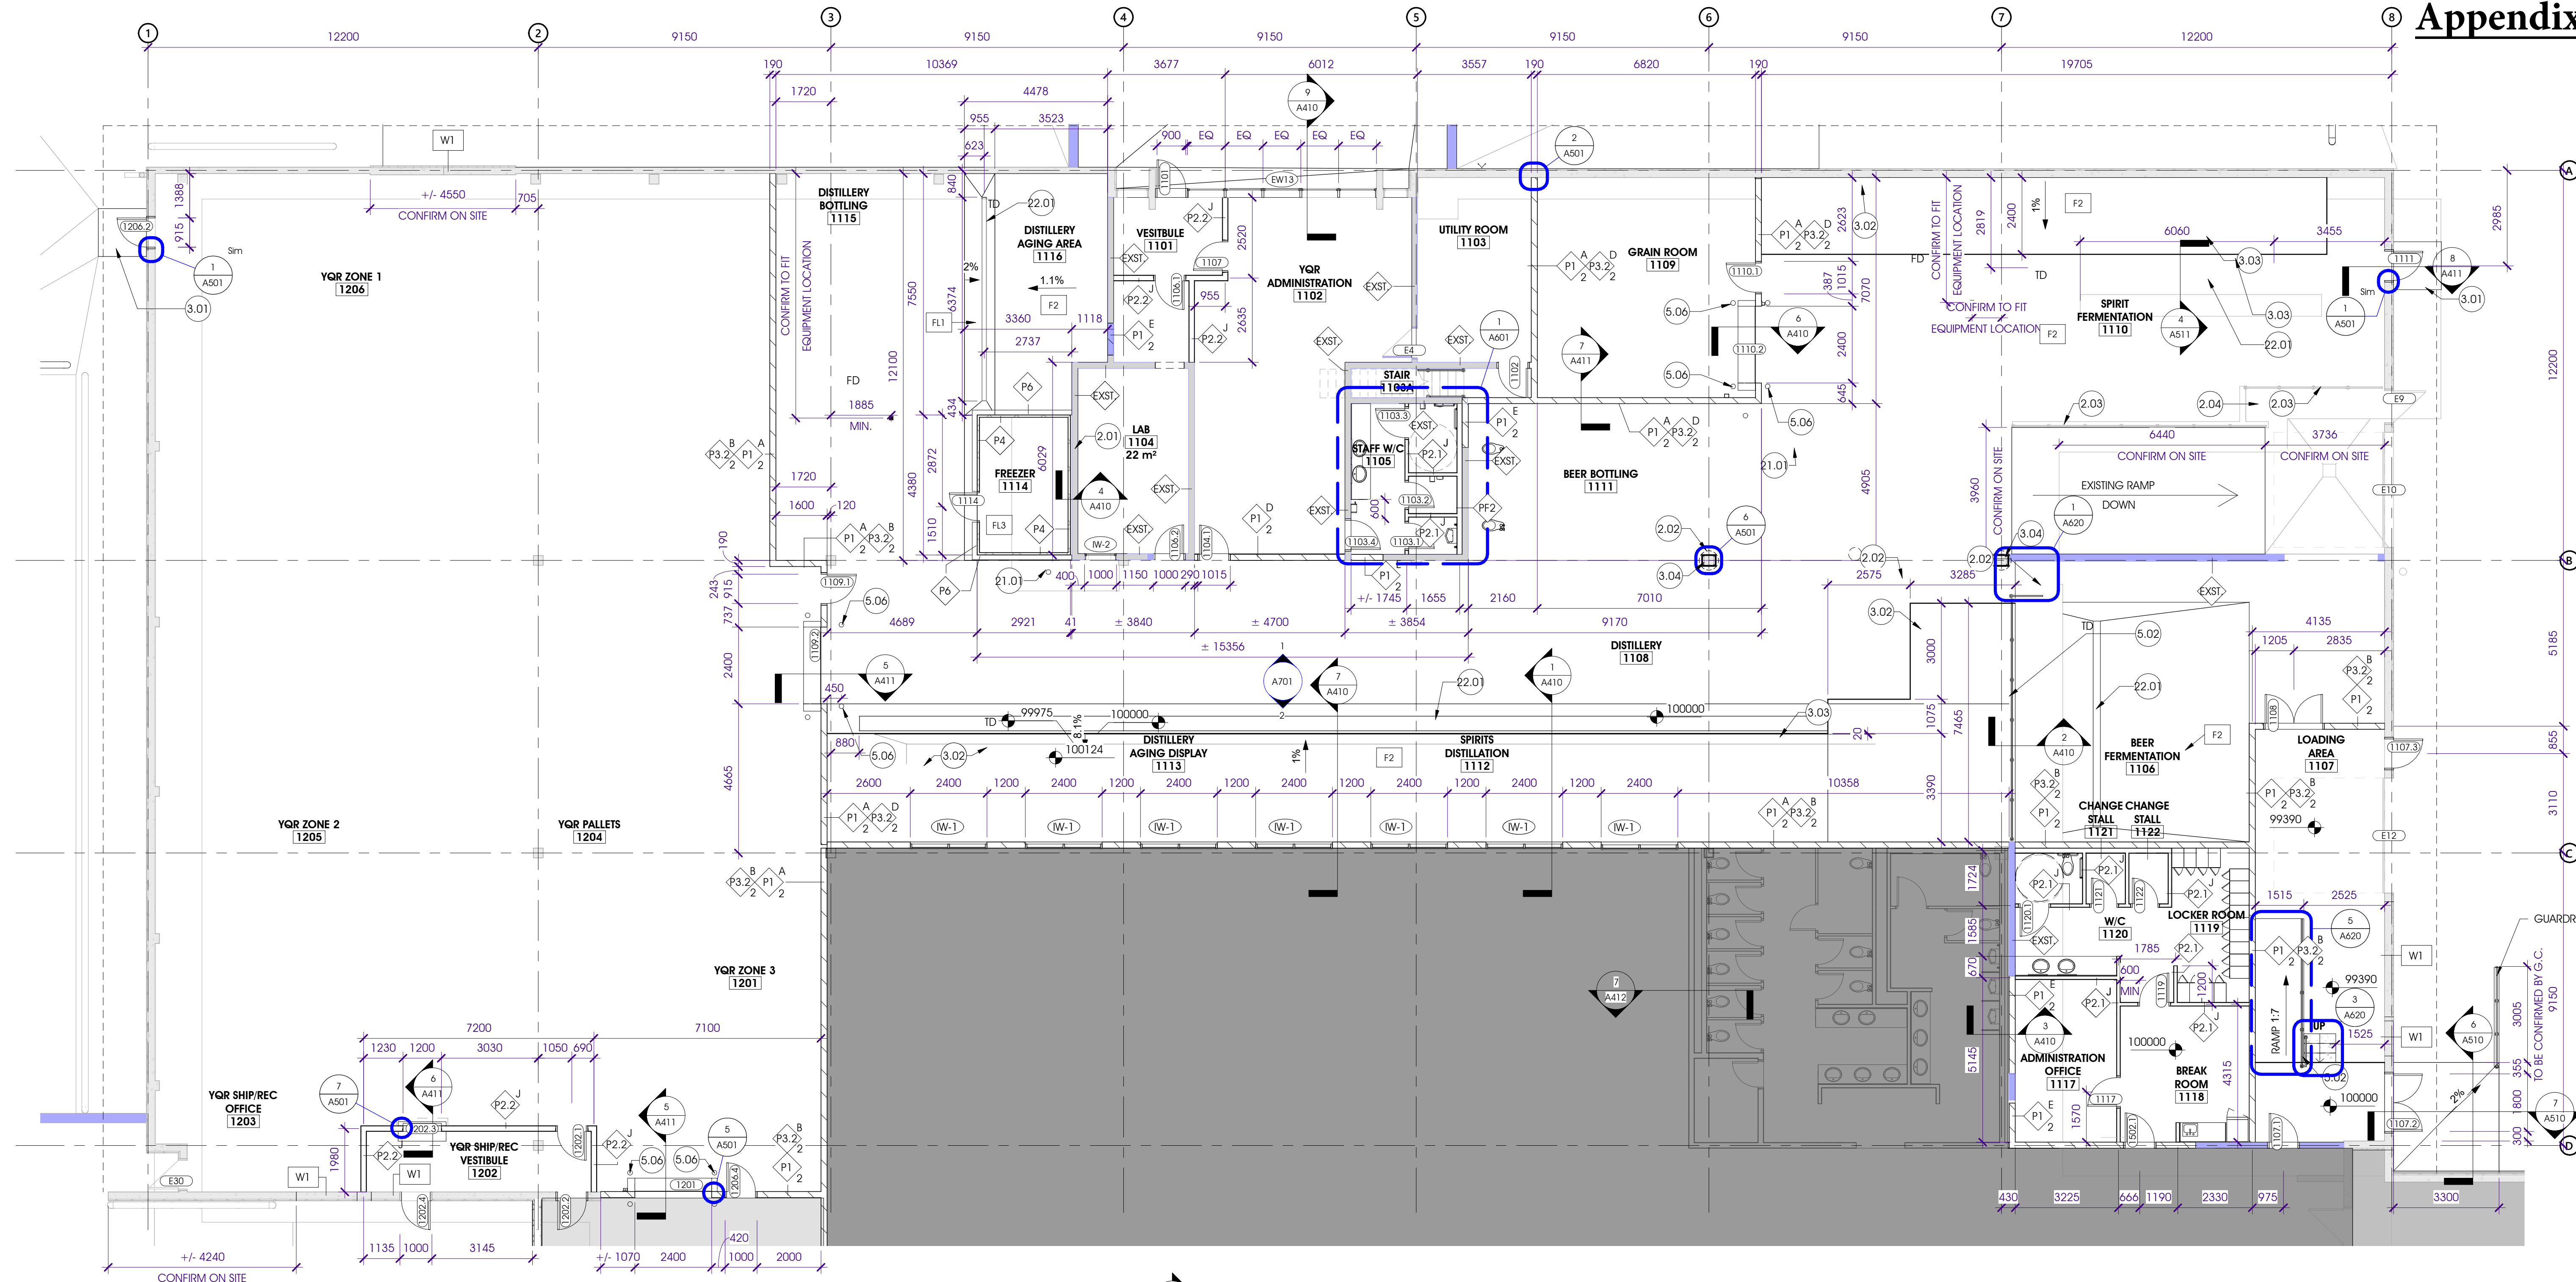

DISTILLERY FLOOR PLAN
SCALE: 1 : 100

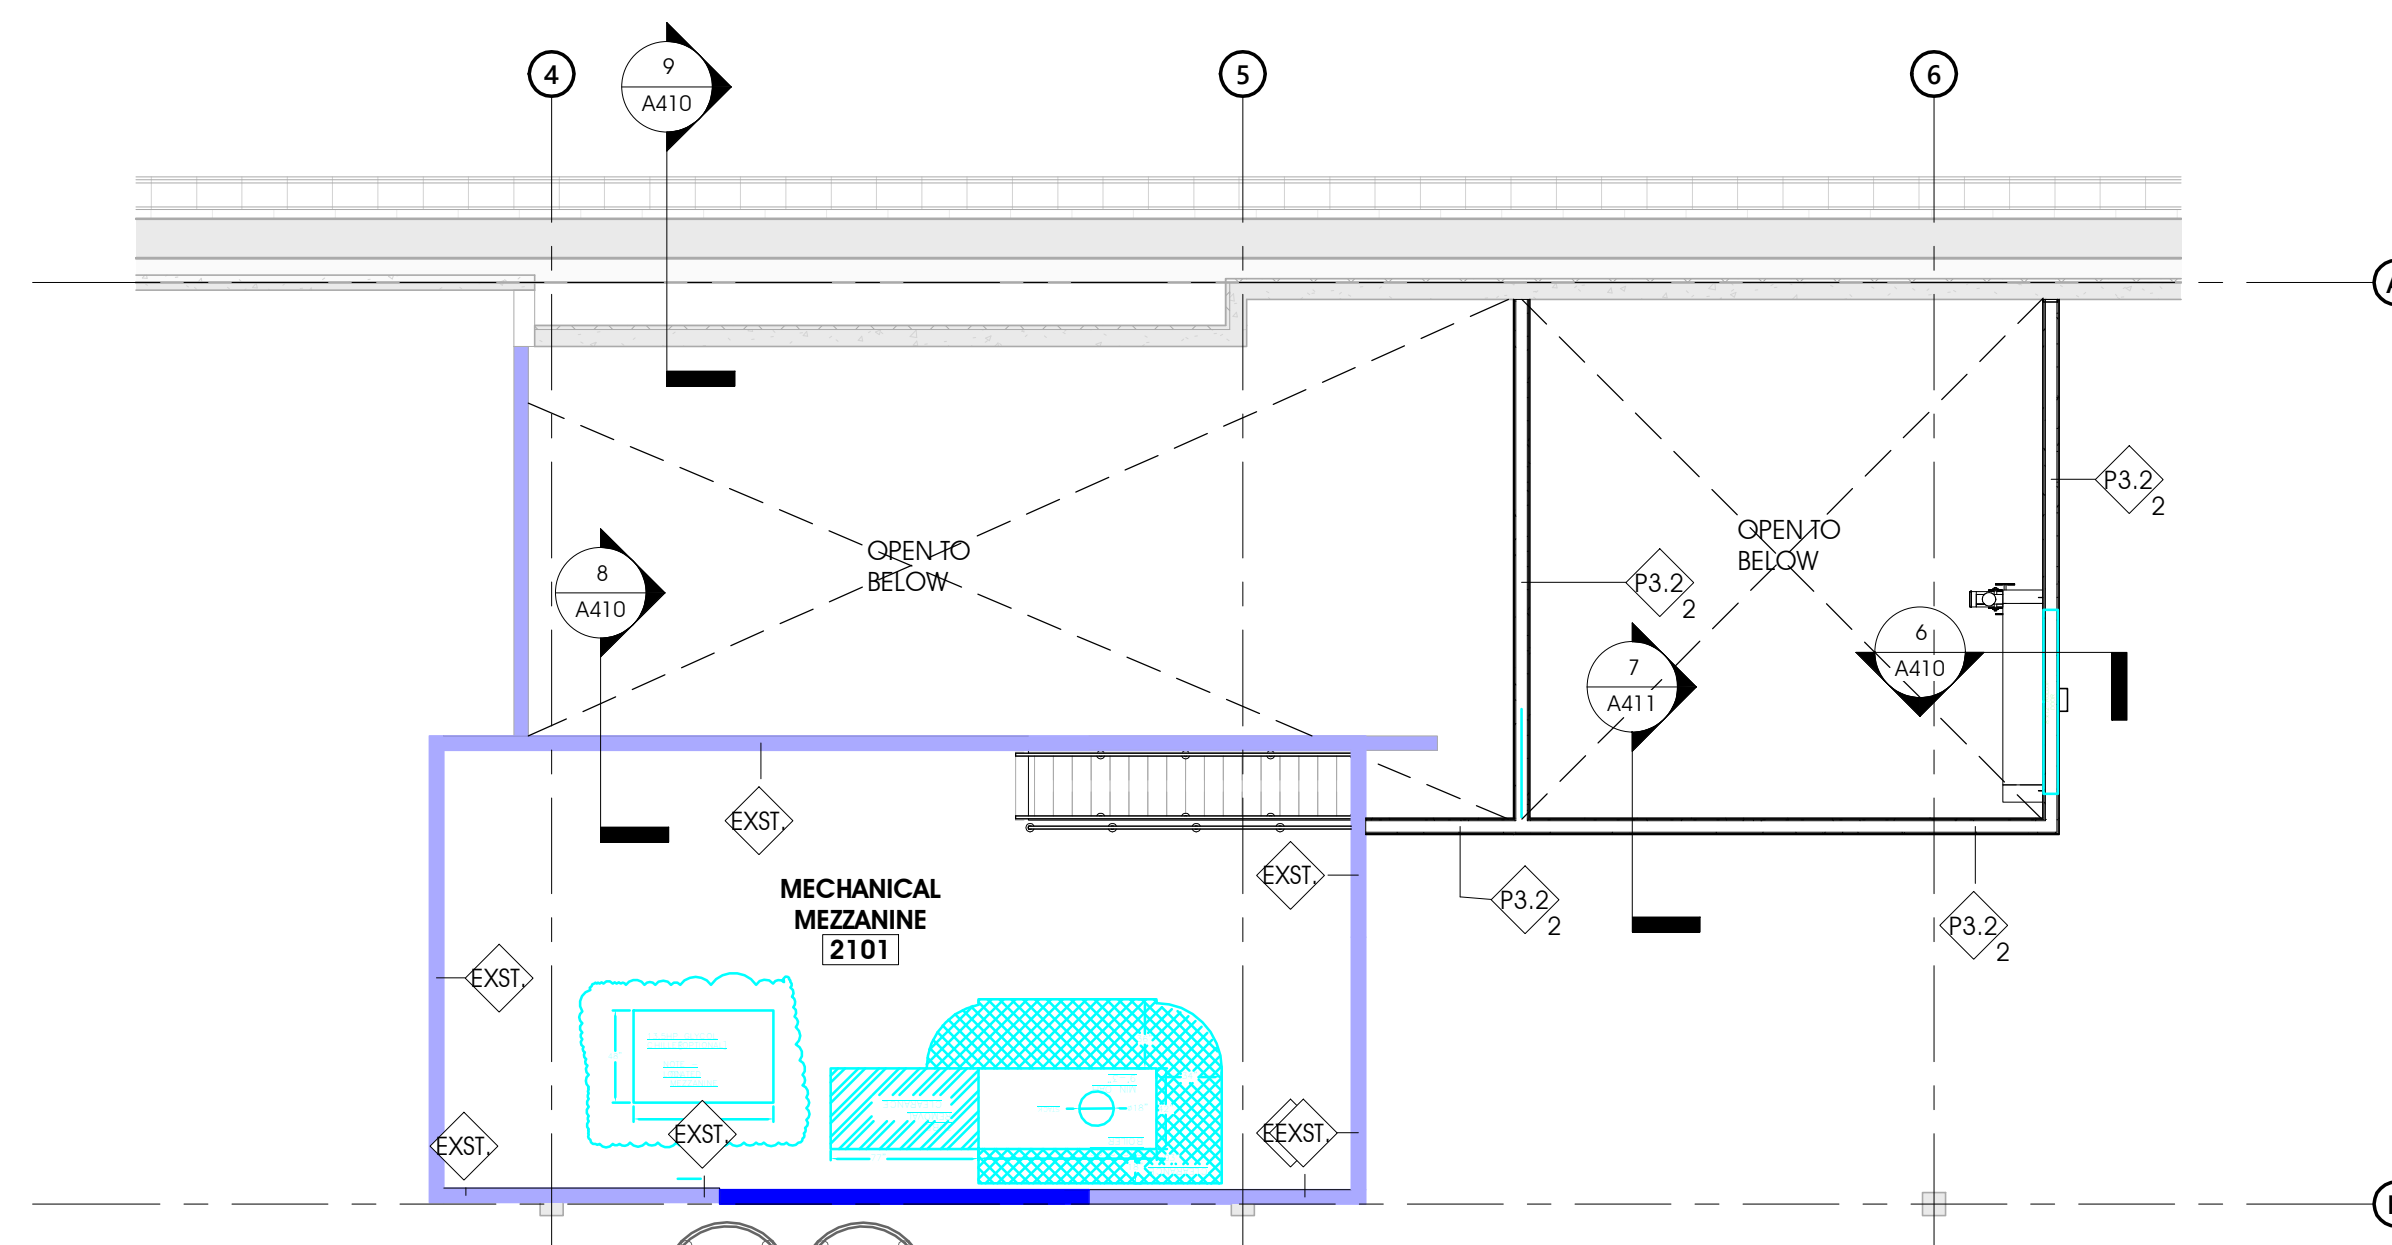

DISTILLERY MEZZANINE
SCALE: 1 : 100

KEYNOTE LEGEND	
Key Value	Keynote Text
2.01	EXISTING WALL TO REMAIN. PATCH AND CLEAN, MAKING READY TO PAINT.
2.02	EXISTING CONCRETE PILE BELOW.
2.03	CLEAN AND REPAINT EXISTING STEEL GUARDRAIL.
2.04	EXISTING CONCRETE STAIR TO REMAIN.
3.01	CONCRETE STOOP. REFER TO STRUCTURAL.
3.02	CONCRETE PAD. REFER TO STRUCTURAL.
3.03	CONCRETE TOPPING SLOPED TO DRAIN.
3.04	EXISTING CONCRETE COLUMN WITH NEW 2HR RATED ASSEMBLY
5.02	MECHANICALLY FASTENED STEEL PIPE GUARDRAIL, PAINTED
5.06	METAL BOLLARDS
21.01	STAND PIPE FOR HOSE STATION AS PER NFCC 4.10.8.1.(2)
22.01	FACILITY TRENCH DRAIN SYSTEM

NOT IN CONTRACT

**FOR INFORMATION ONLY
NOT FOR CONSTRUCTION**